


SECTION B-B

Looking West
SCALE: 1:33 mm

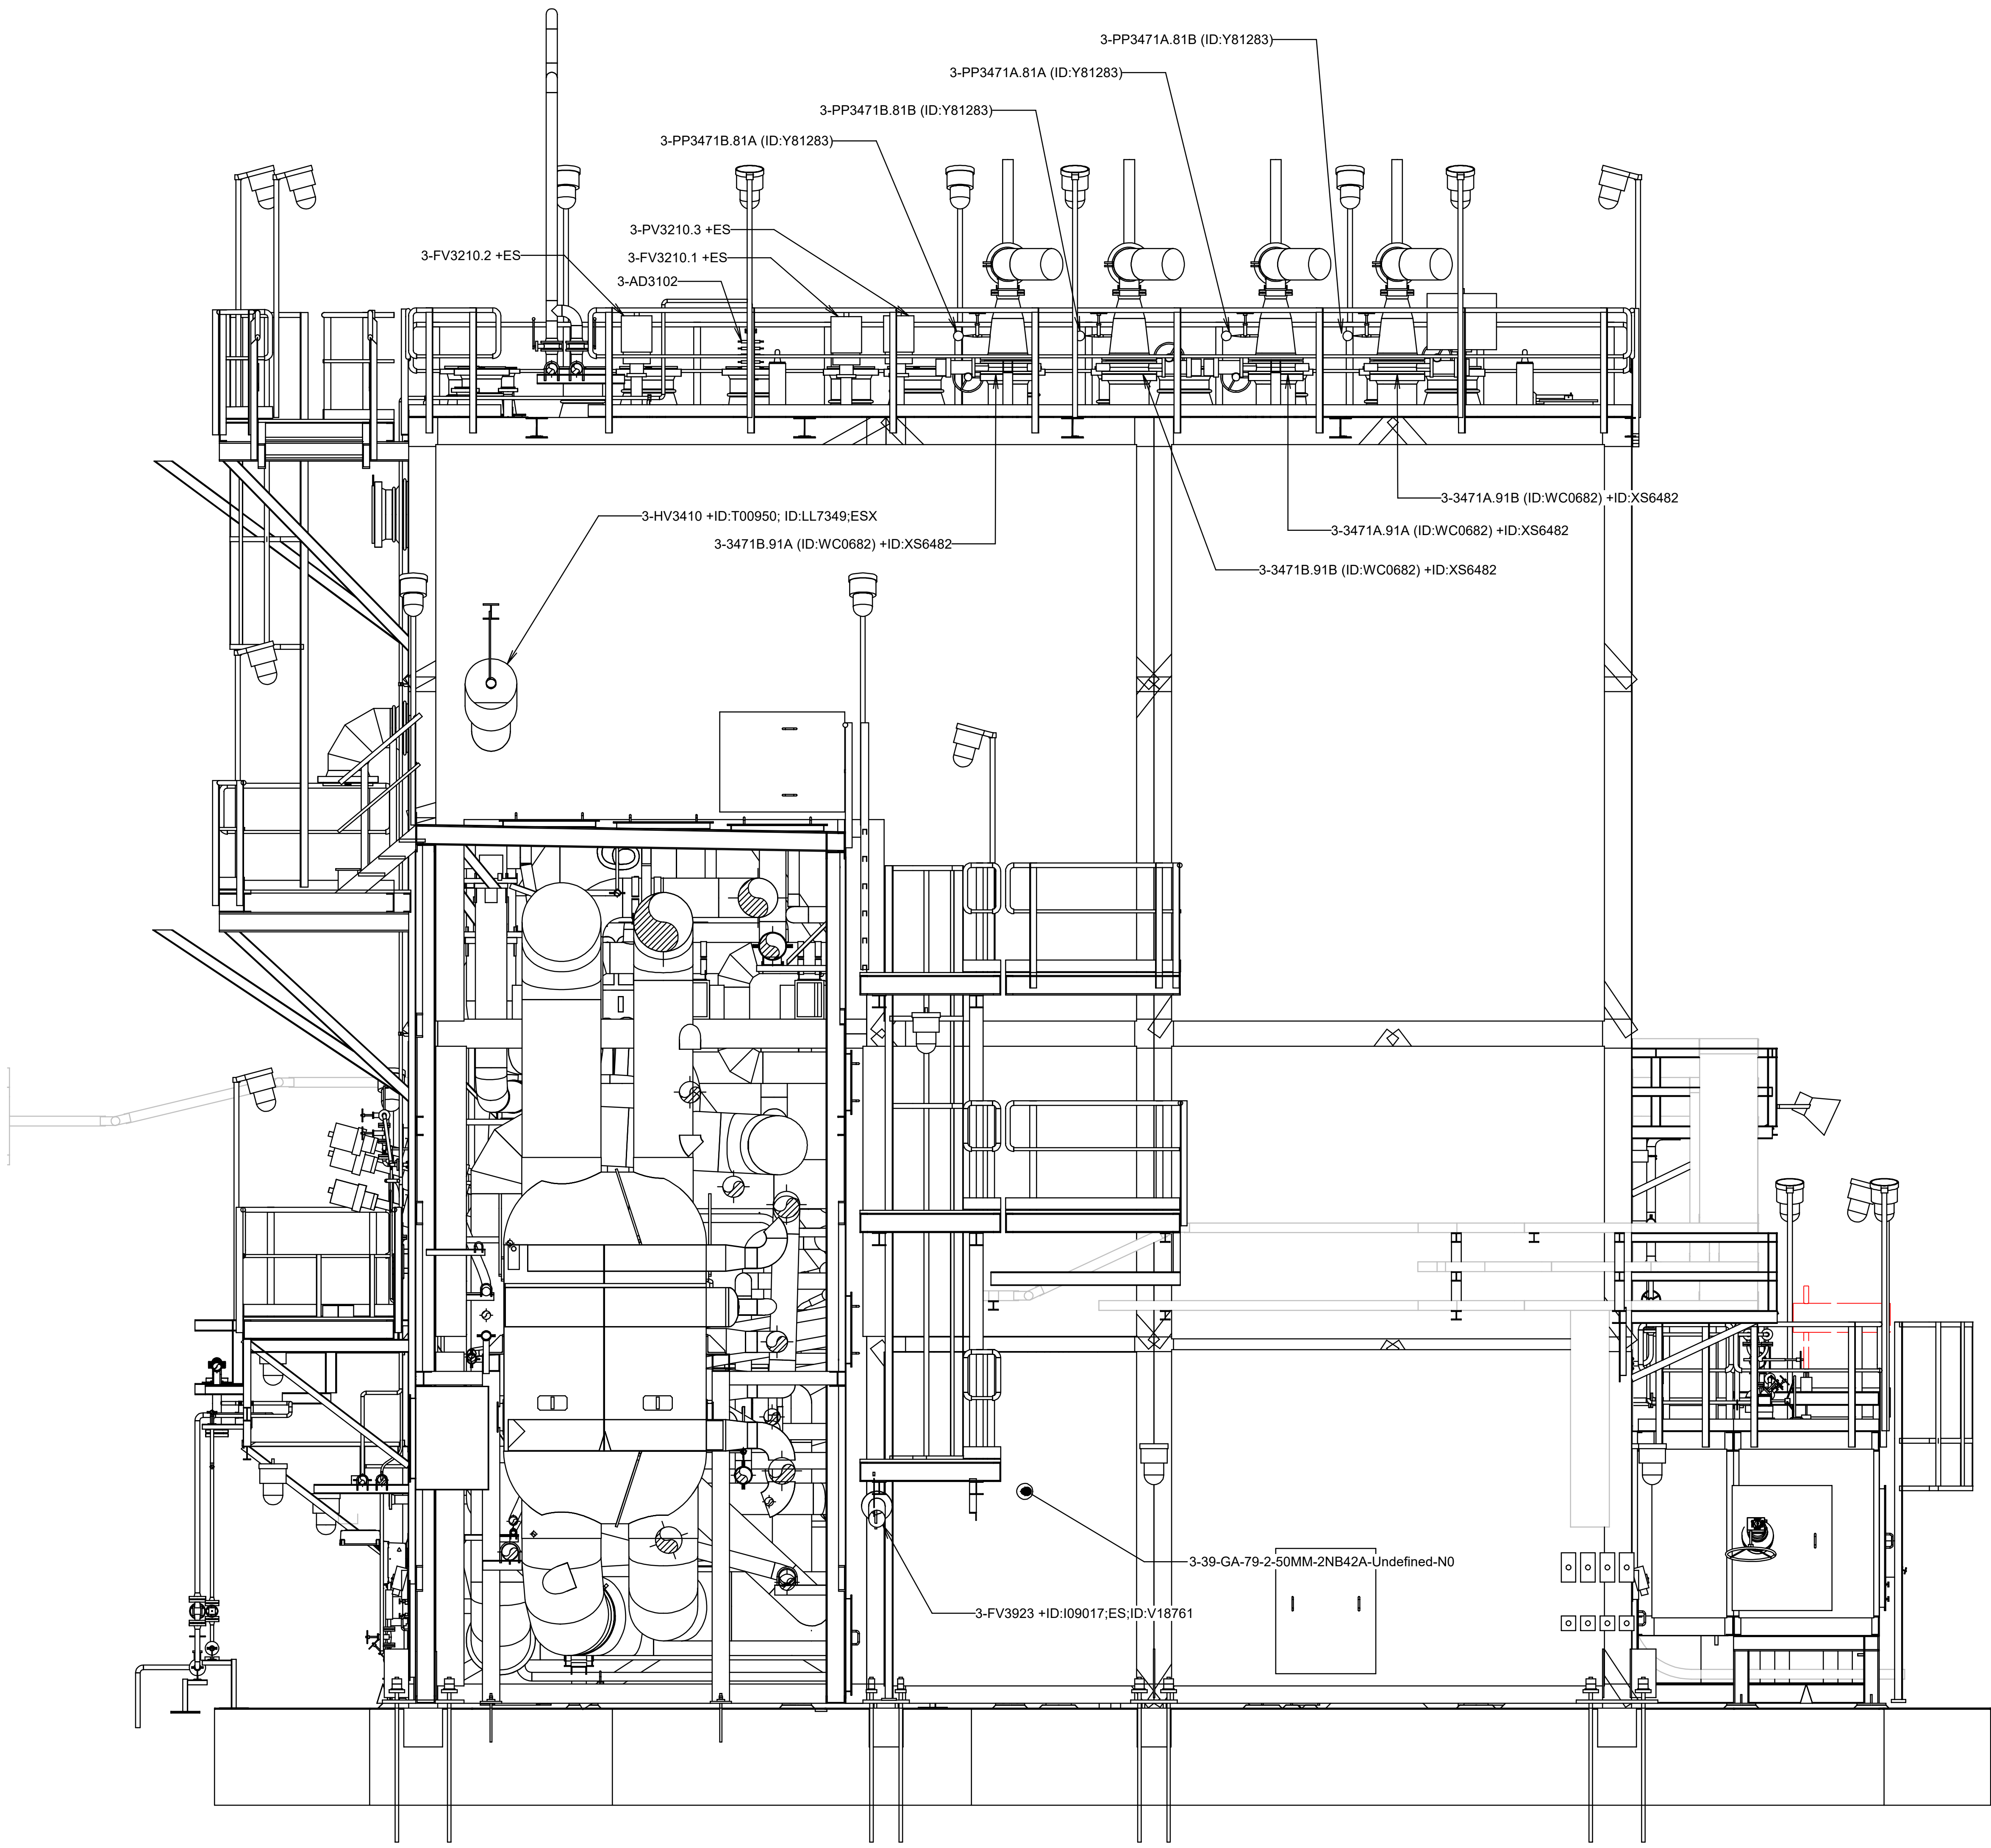

REFERENCE - SAMPLE

CONFIDENTIAL



LINDE GmbH
LINDE ENGINEERING
D-82049 PULLACH

Title: COLD BOX OUTSIDE - PIPING PLAN SECTION B-B				Scale: 1:33
Linde Drawing No.	&ASU 0039 L-ZR 1001	Sheet	08 OF 19	Size: A0