
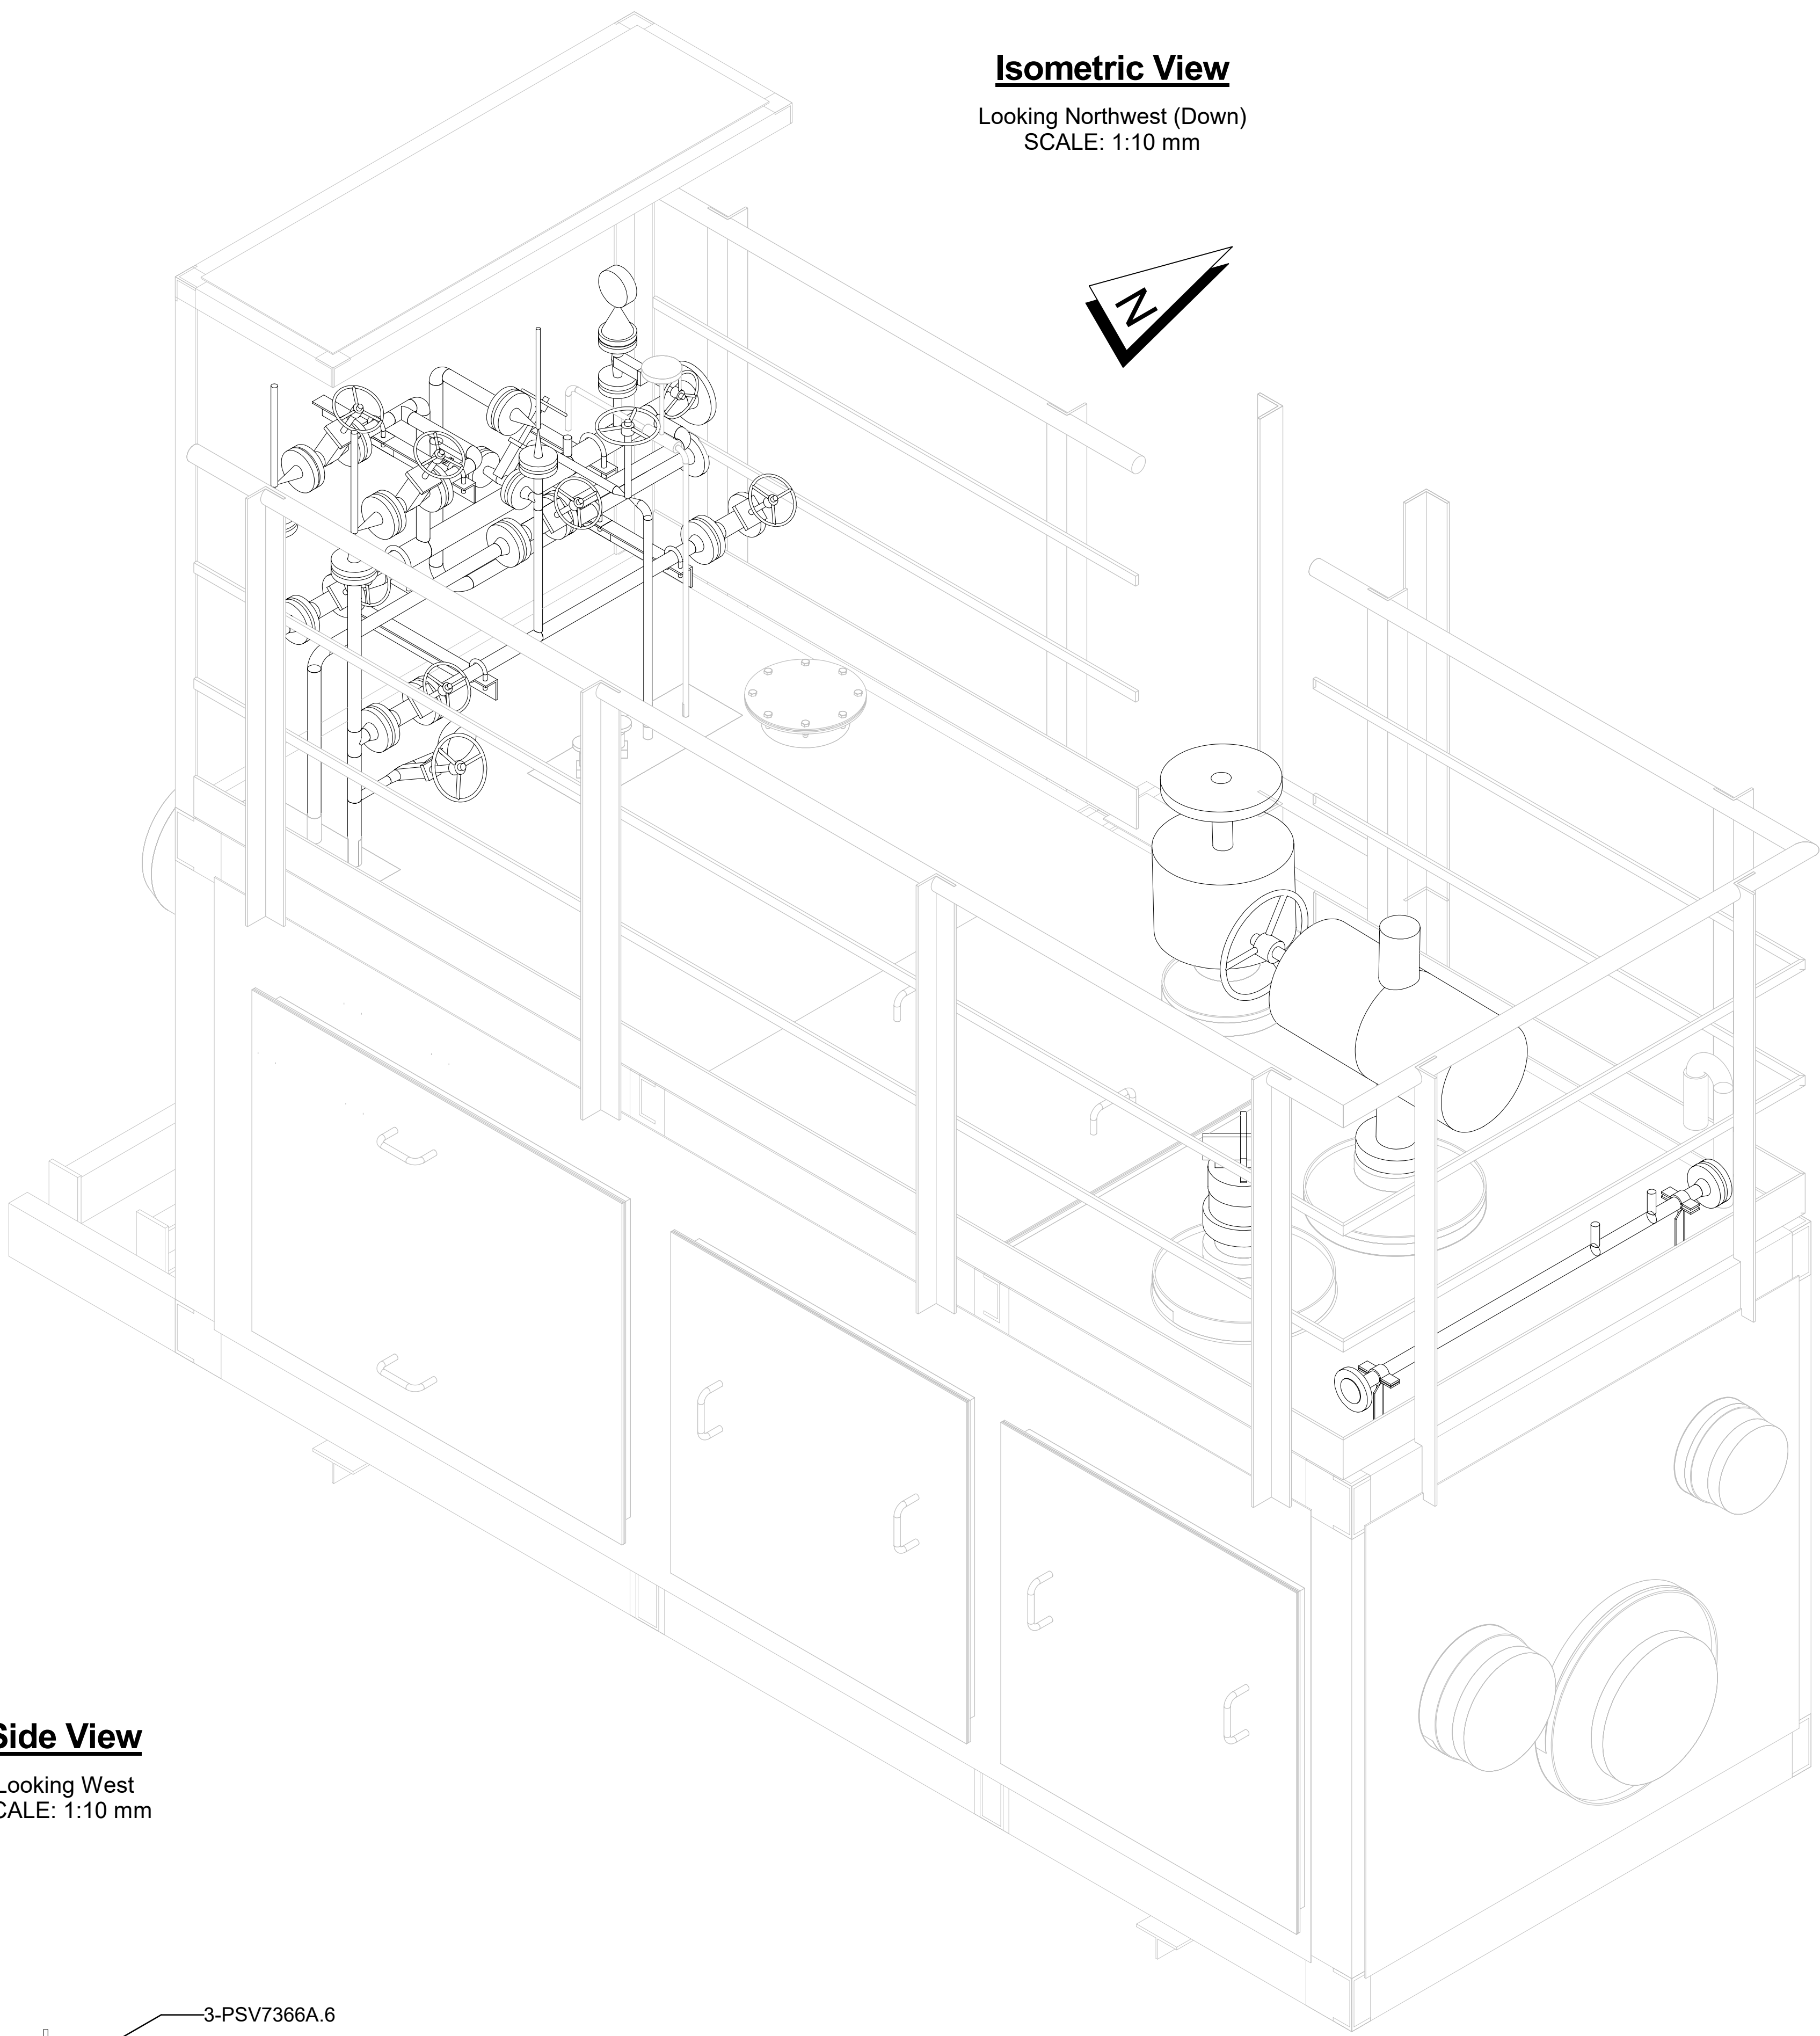



Isometric View

Looking Northwest (Down)  
SCALE: 1:10 mm

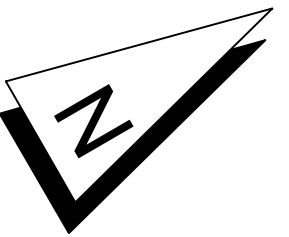


Top View

Looking Plan  
SCALE: 1:10 mm

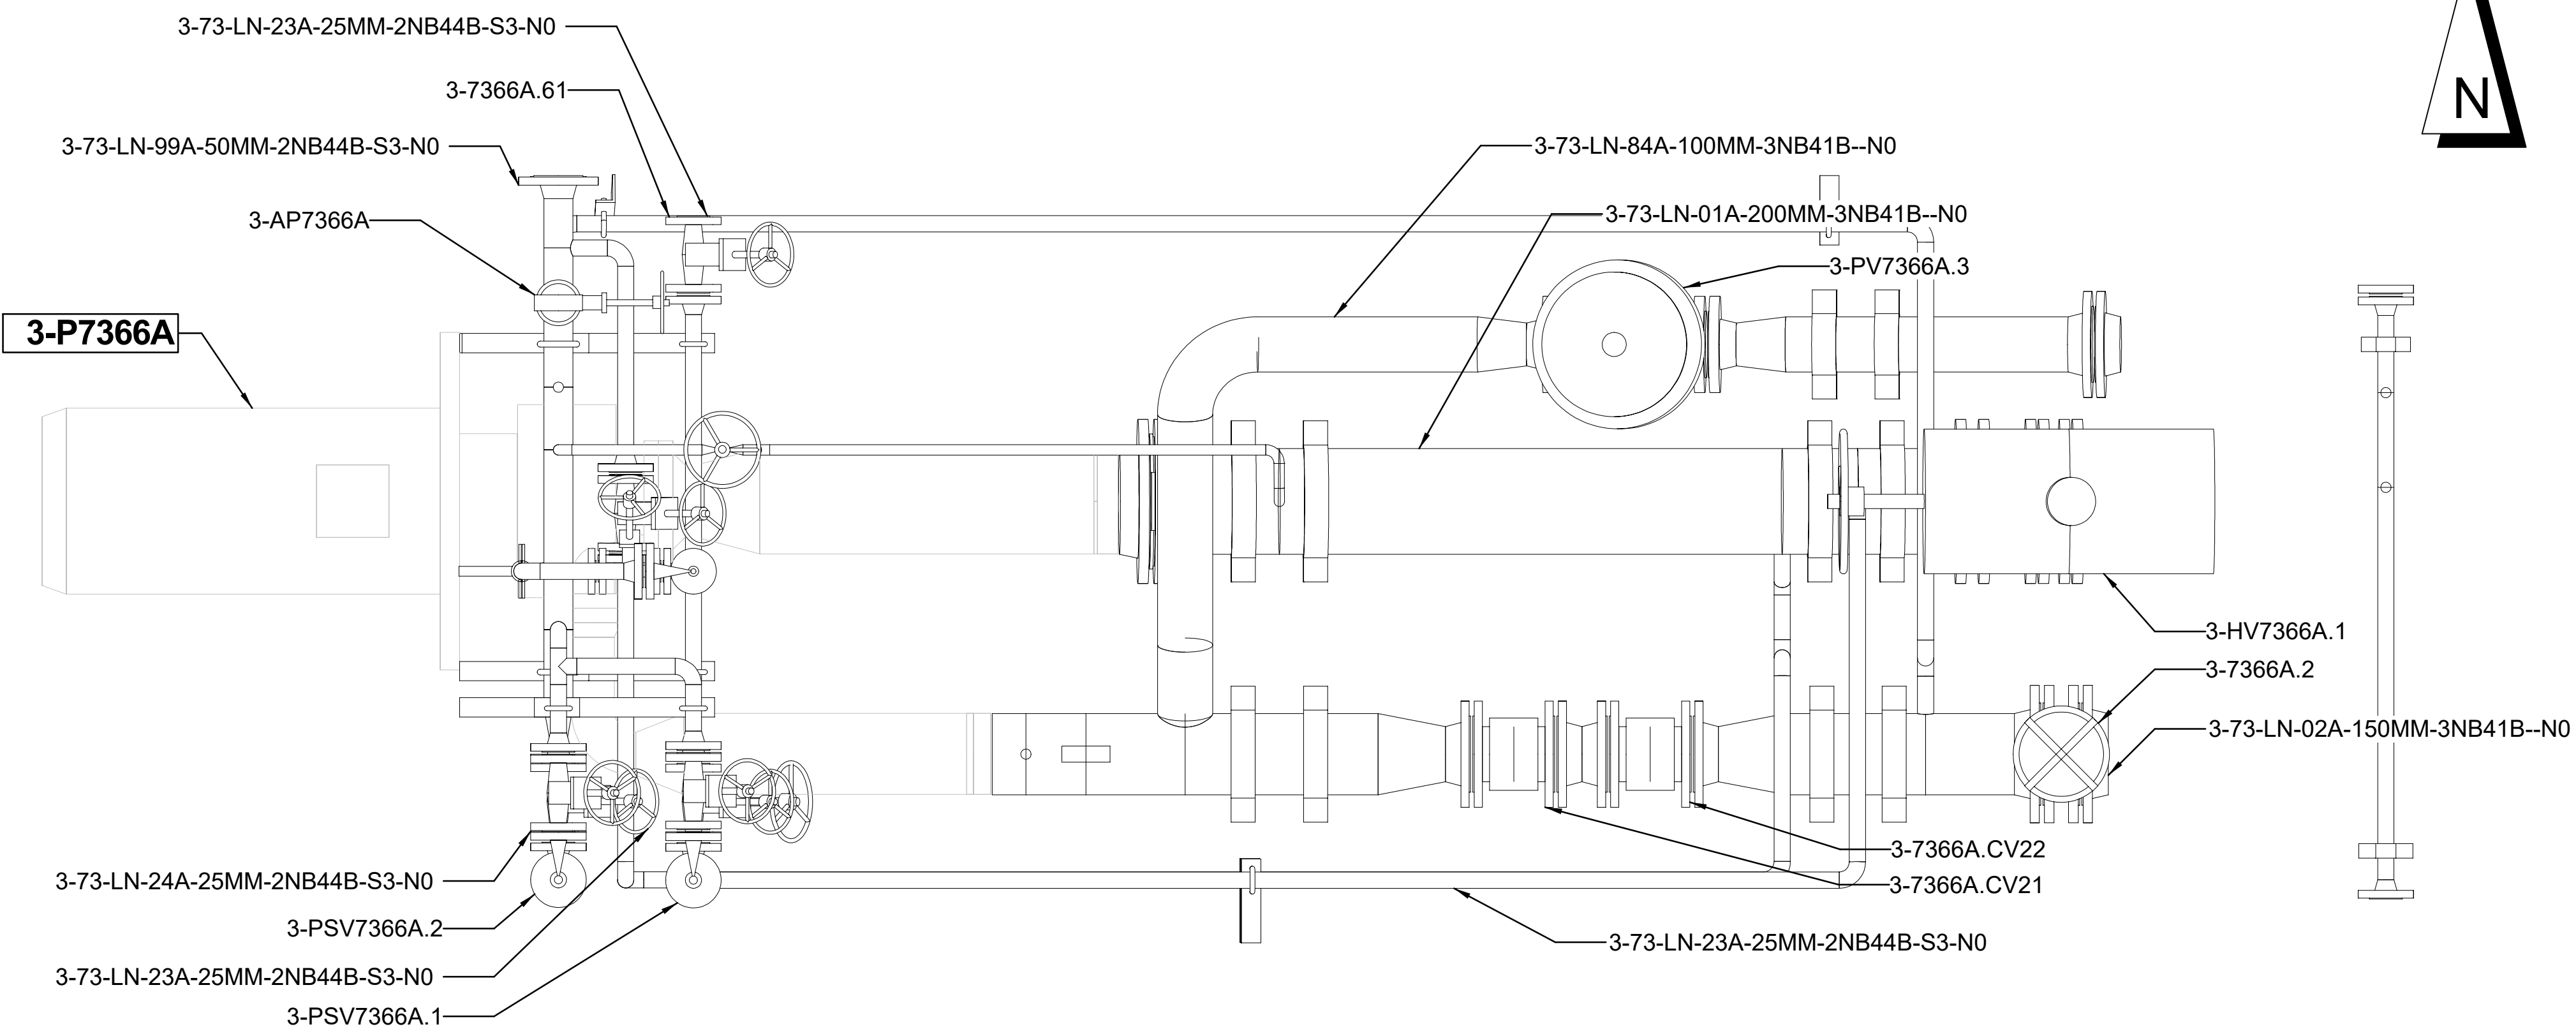


Front View

Looking North  
SCALE: 1:10 mm

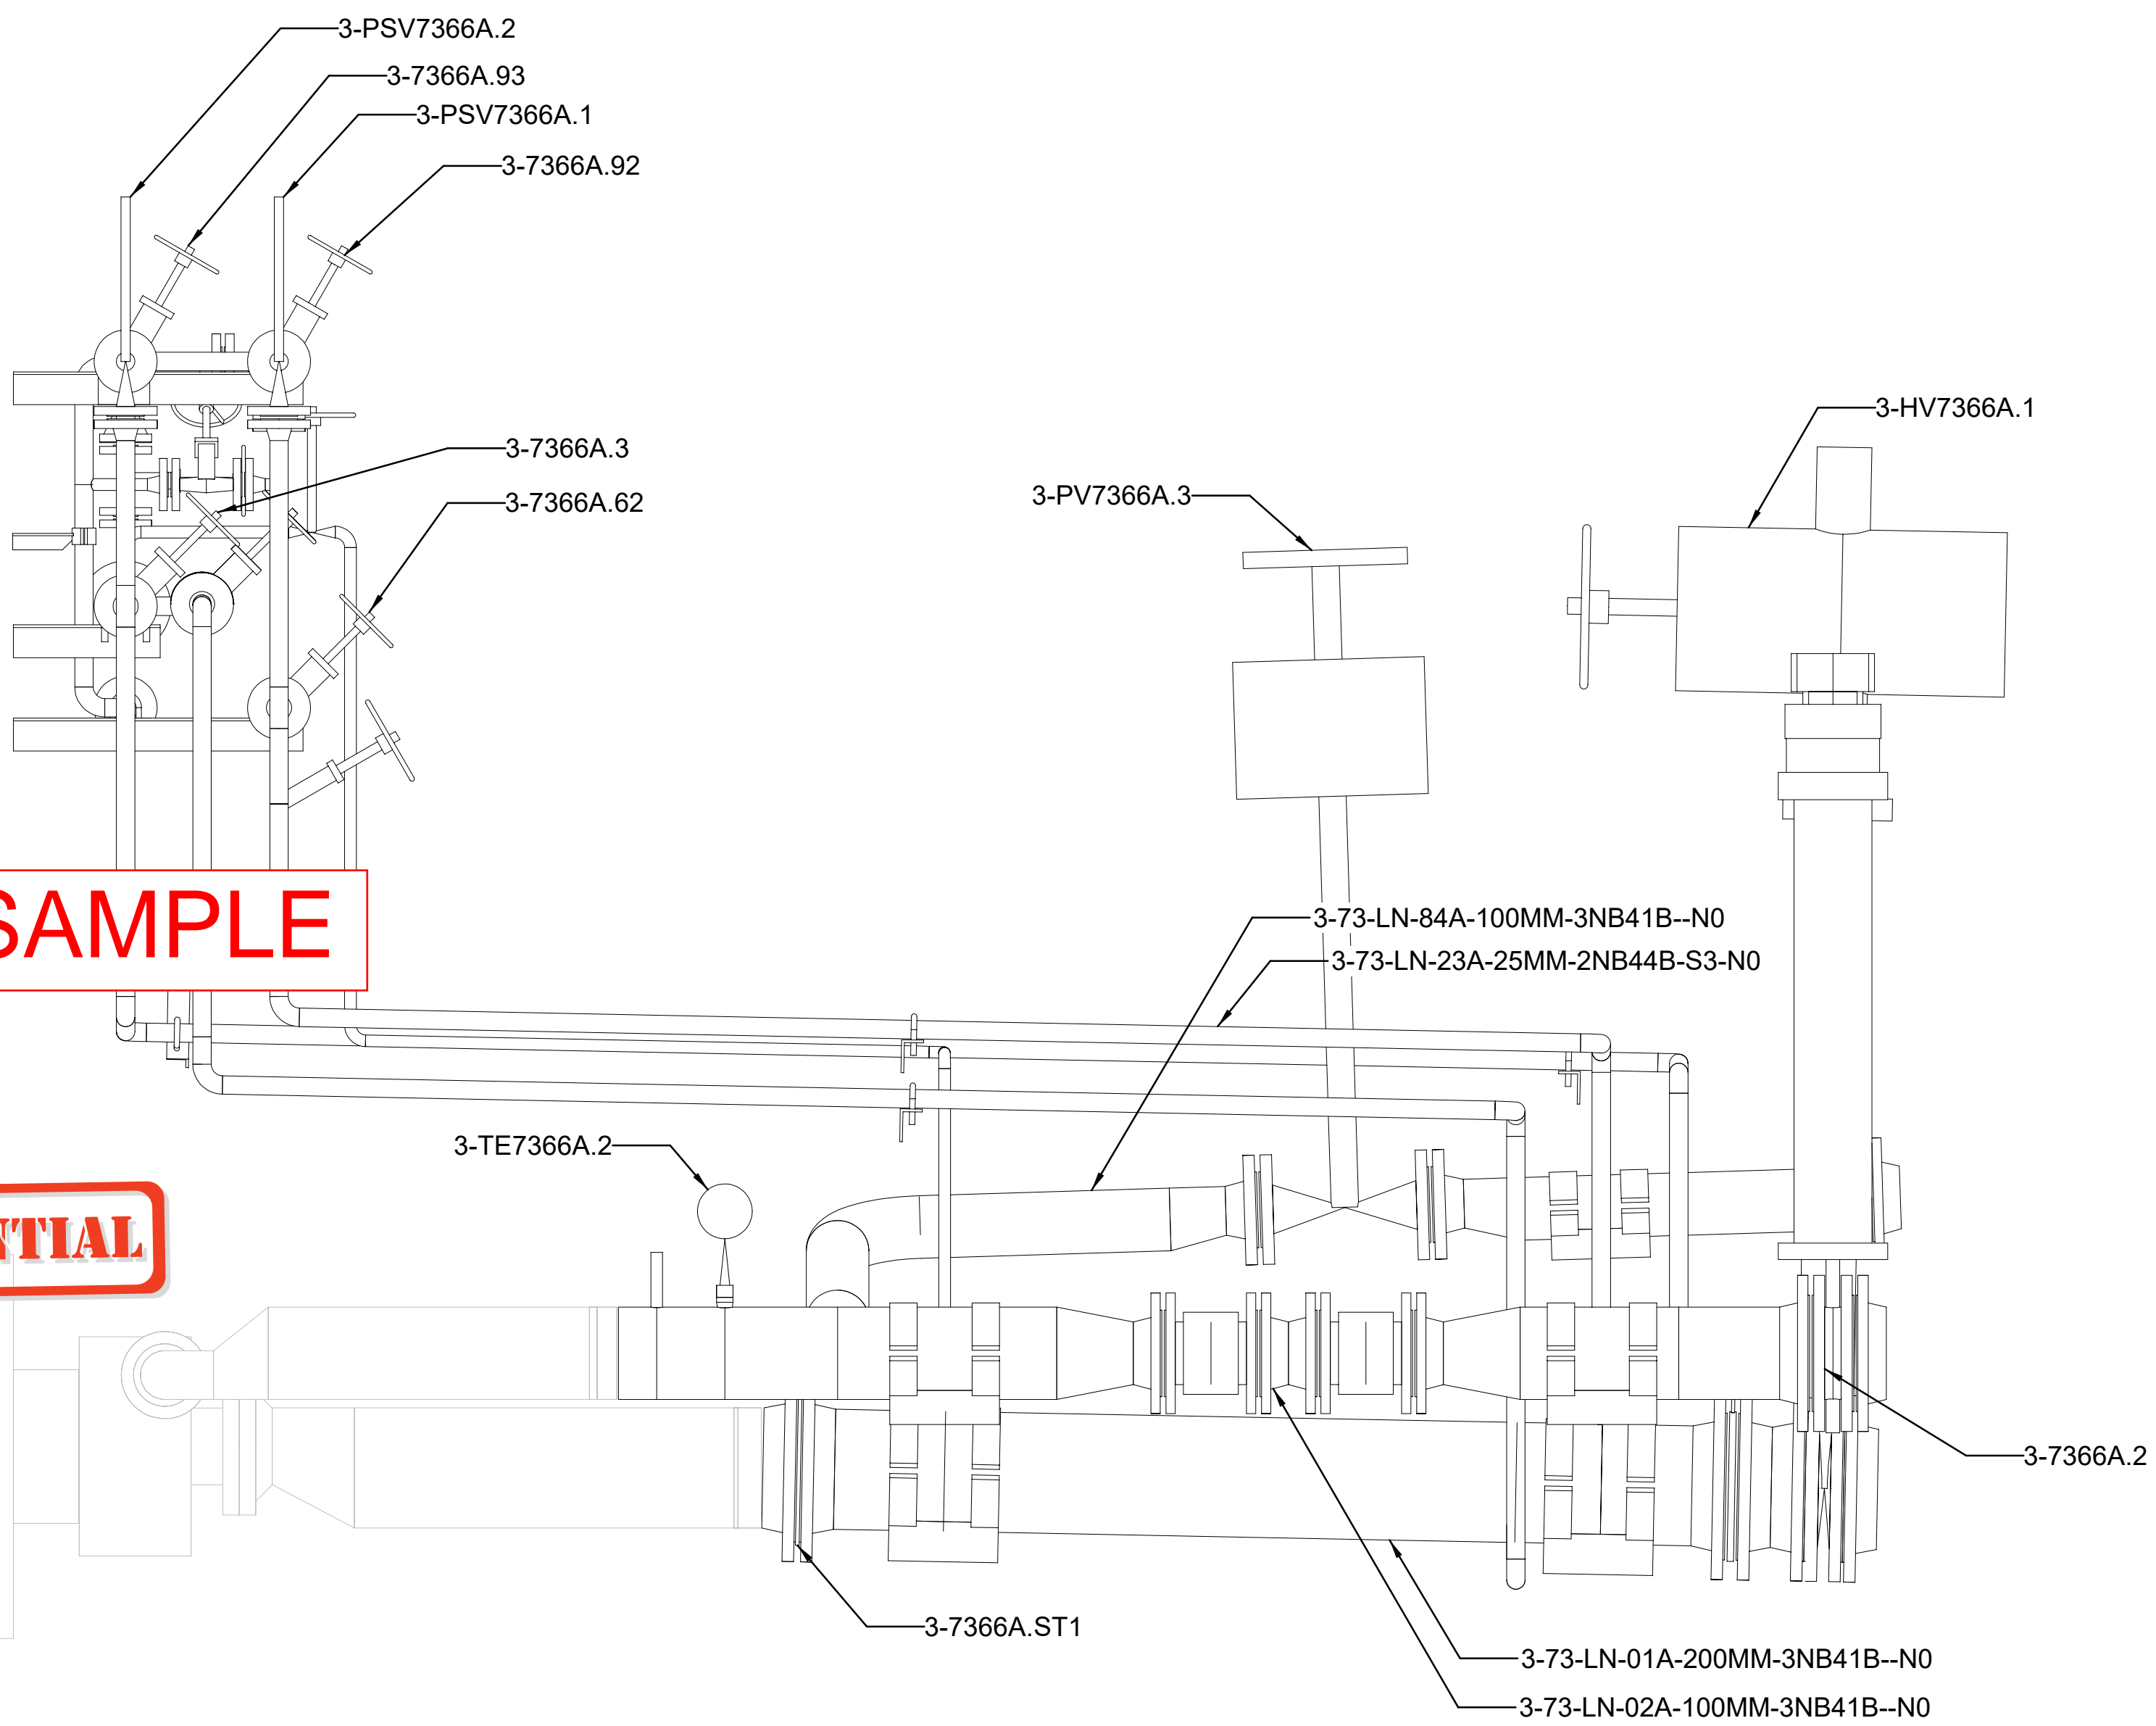

Side View

Looking West  
SCALE: 1:10 mm

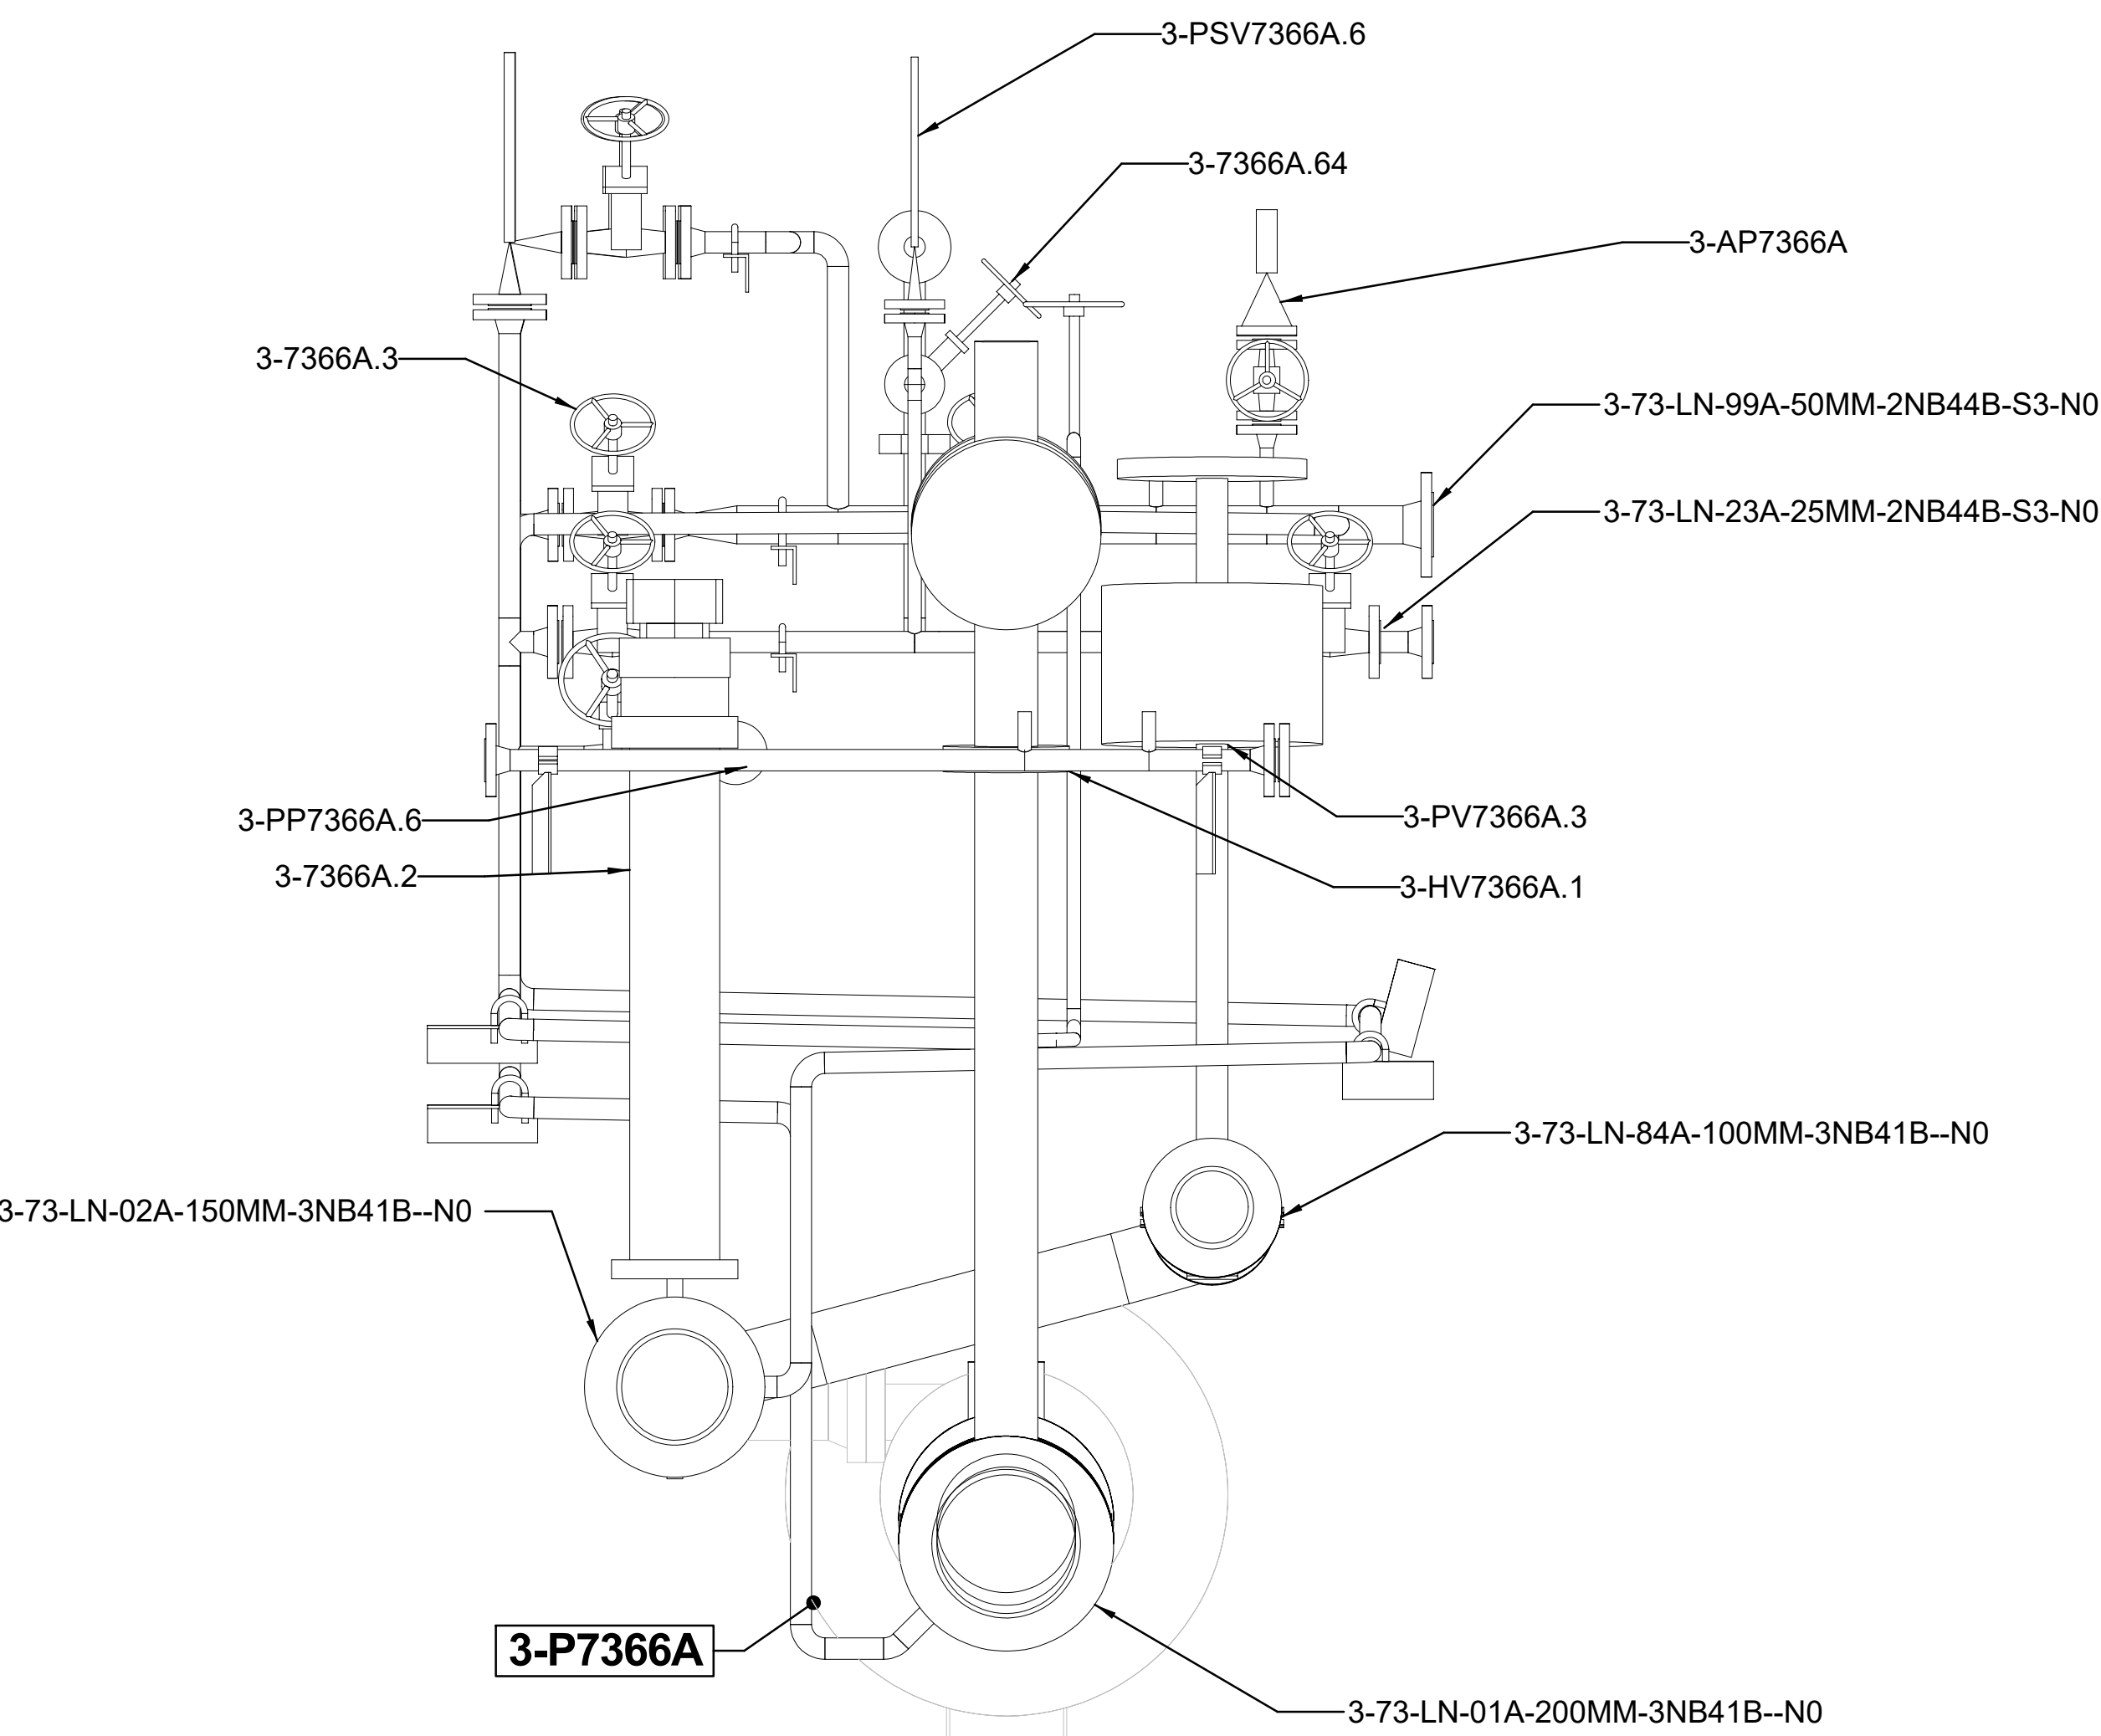

REFERENCE - SAMPLE

CONFIDENTIAL



LINDE GmbH  
LINDE ENGINEERING  
D-82049 PULLACH

Confidential: The reproduction, distribution and utilization of this document as well as the communication of its contents to others may be subject to the terms and conditions of the LDC contract (No. 555022125). All rights reserved in the event of the grant of a patent, utility model or design.			
Linde Project No.: 1510CD77		Linde Job Code.: Plock ASU III	
Title: PIPING PLAN CA76			Scale: 1:10
Linde Drawing No.: &ASU 0076 L-ZR 7366 (EN)	Sheet: 1 of 1	Size: A0	

&ASU 0076 L-ZR 7366 (EN)